


SAMPLE DRAWING

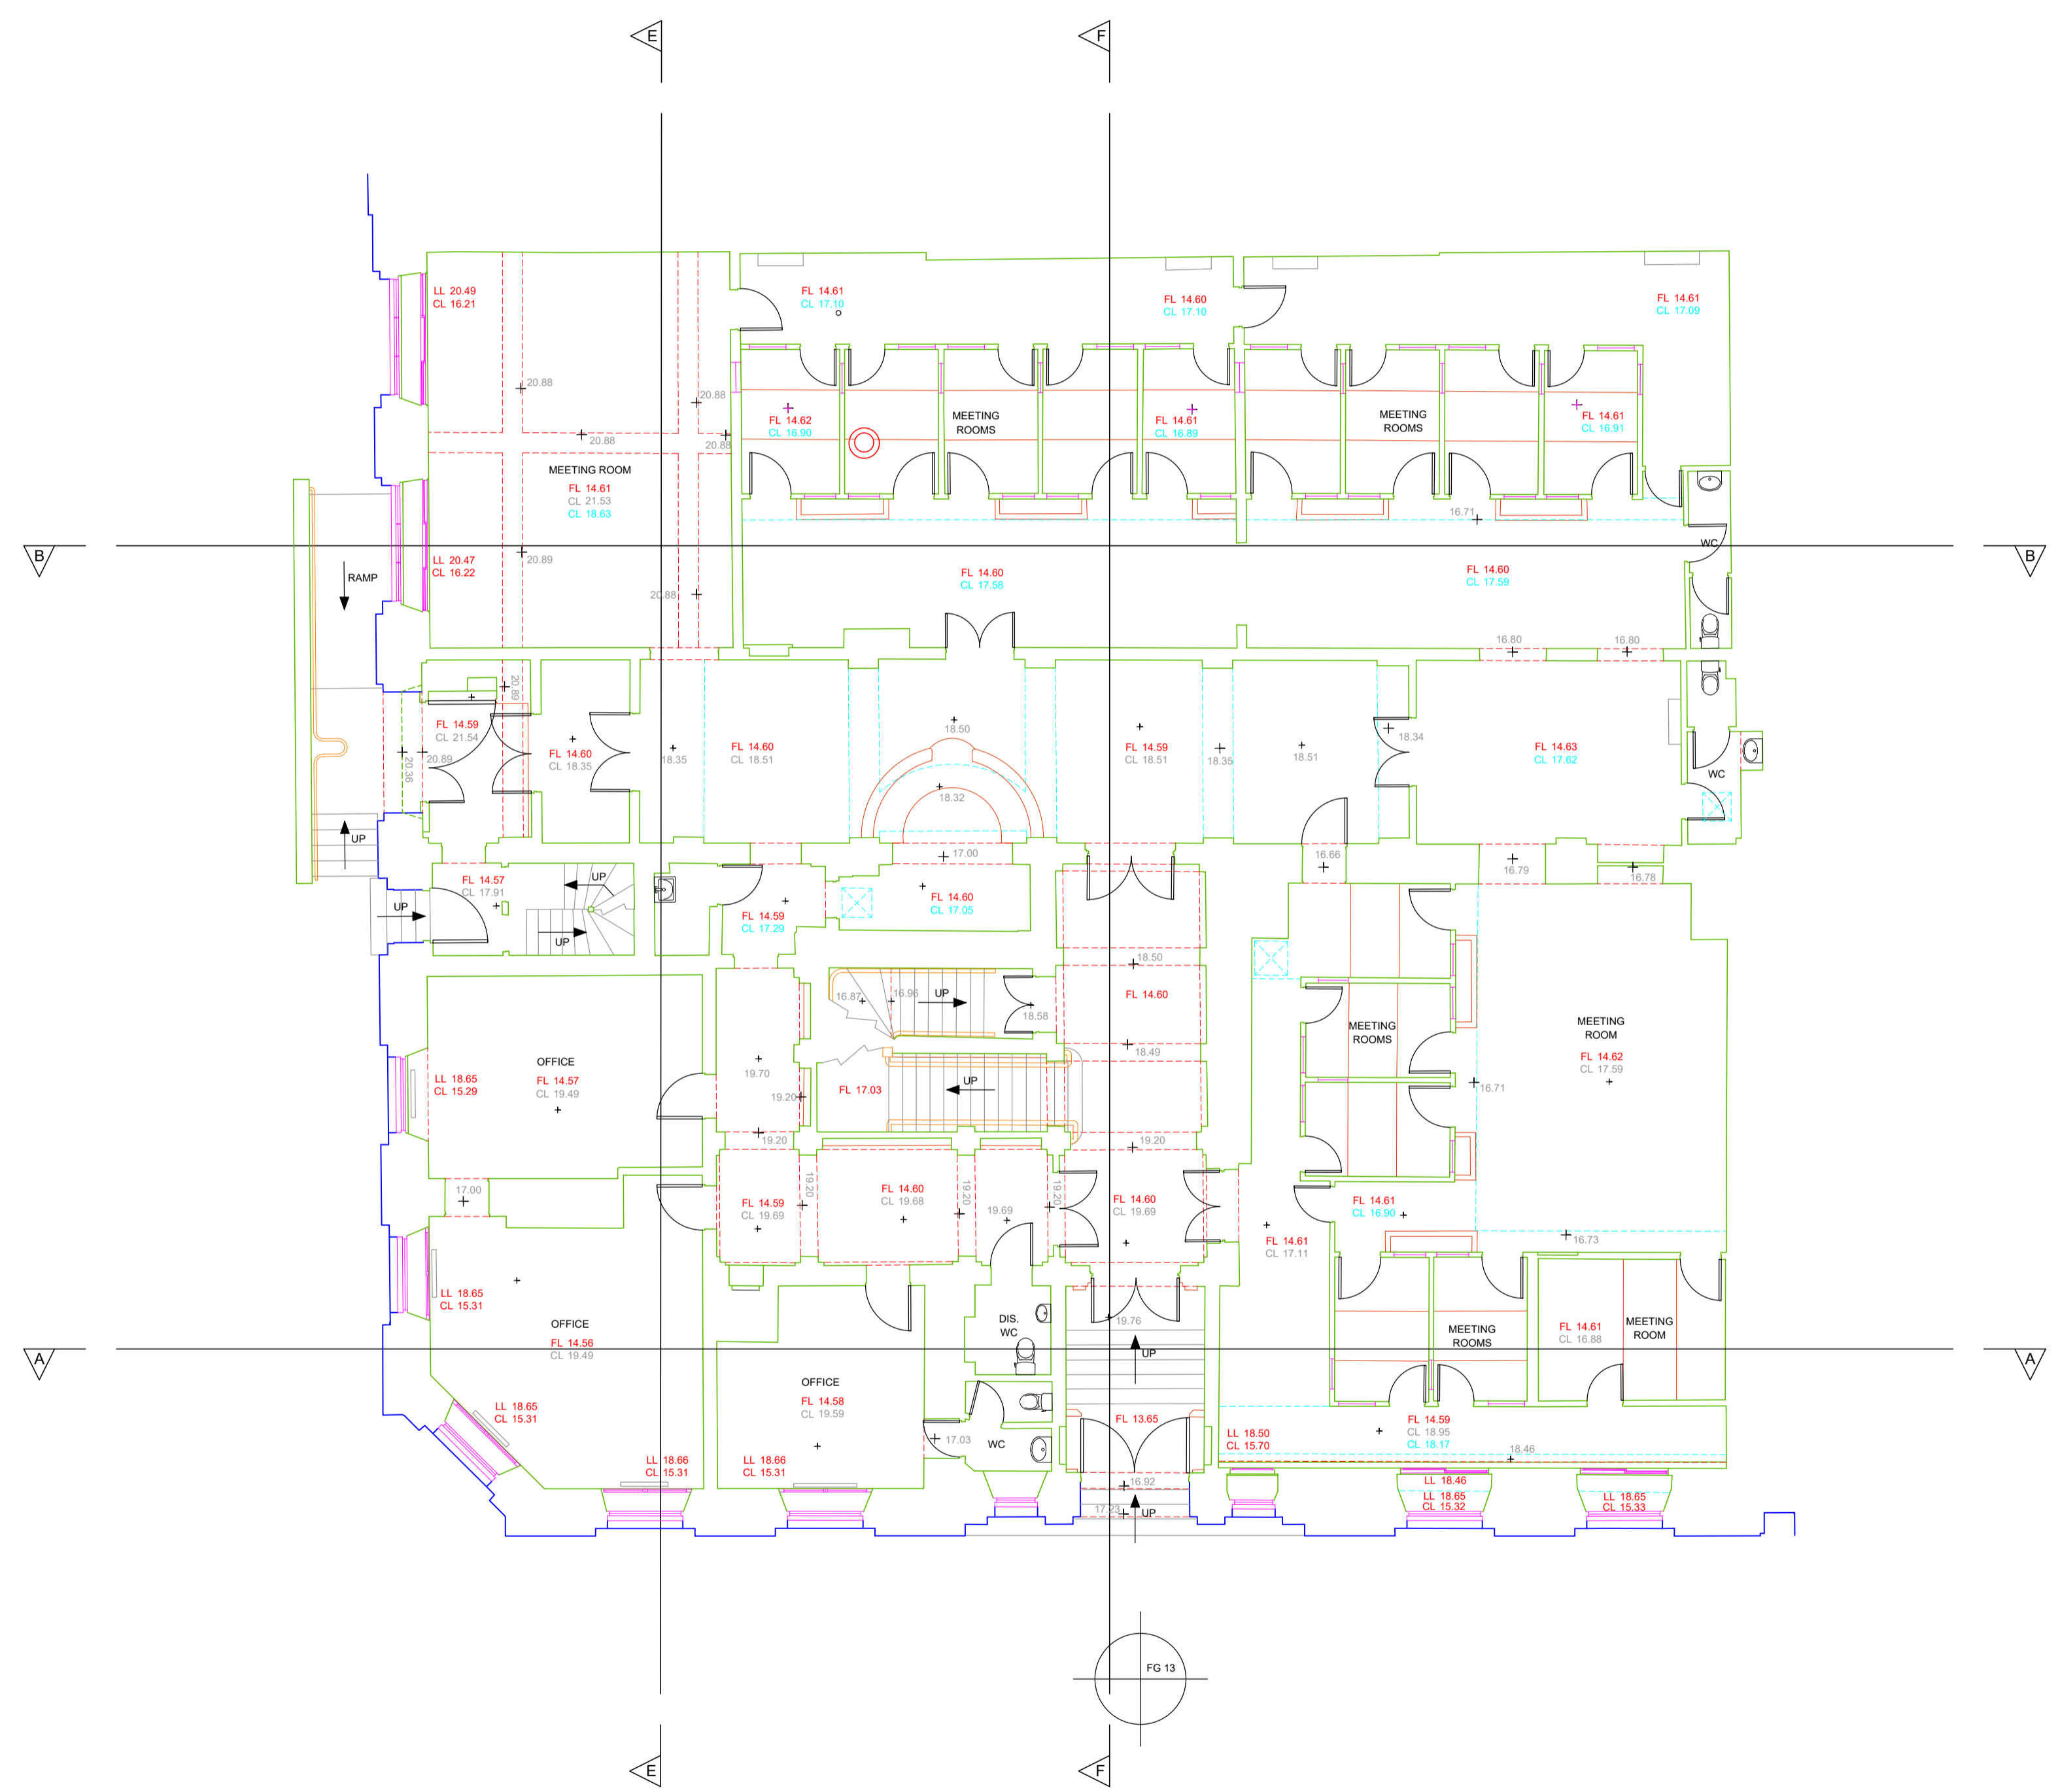

NOTES:-

i) All survey levels are related to OS Datum (National GPS Network).

ii) Whilst 4Site Surveys has made every effort to locate all topographical and building features we cannot accept responsibility for any features which may be omitted if they are obscured from view for any fixed or temporary reason at the time of the survey taking place.

Legend:-

AV - Air Valve	MC - Mercury Cover
BH - Borehole	MH - Manhole
B - Bollard	MKR - Marker
BT - British Telecom Cover	MR - Mooring Ring
C - Cover(unknown service)	MR - Mooring Ring
CL - Cliff Level	OBM - O.S. Benchmark
COL - Column	OHM - Overhead Wire
CT - Cable Telecom Cover	OTP - O.S. Trig Point
D - Drain	P - Post
DK - Drop Kerb	PM - Parking Meter
EC - Electricity Cover	P/LN - Elec. Pylon
EL - Eaves Level	RE - Rodding Eye
EP - Electricity Pole	RL - Ridge Level
ER - Earth Road	RS - Road Sign
EH - Fire Hydrant	SP - Sign Post
FL - Floor Level	SV - Stop Valve
G - Gully	T - Toby
GC - Gas Cover	TTT - Trial Pit
GPO - Post Office Box	TL - Traffic Lights
GT - Gas Toby	TP - Telegraph Pole
IC - Inspection Cover	TV - Cable T.V. Cover
IL - Invert Level	VP - Vent Pipe
KL - Keep Left Bollard	WC - Water Cover
LB - Lighting Bollard	WH - Wall Head Level
LL - Level Level	WL - Water Level
LP - Lamp Post	WM - Water Meter
LT - Lighting Tower	WT - Water Toby

B	Levels Added	25.01.16	ACF	FG
A	SURVEY CONTROL POINTS ADDED	10.11.15	ACF	FG
Rev.:-	Description:-	Date:-	By:-	Checked

4 Site Surveys
 19 CRAIGHIRST ROAD
 MILNGAVIE
 GLASGOW
 G62 7RG

Tel./Fax.:- 0141 956 6764
 email:- alan.foggo@4-sitesurveys.co.uk
 Web.:- www.4-sitesurveys.co.uk

Client:-

Job Title:-

**280 GEORGE STREET
 GLASGOW**

Drawing Title:-		Date:-
GROUND FLOOR PLAN		OCTOBER 2015
		Scale:-
		1:100@A1
Surveyed By:-	Drawn By:-	Checked :-
ACF / FG	ACF/FG	ACF
Job Number :-	Drawing No.:-	Rev.:-
4SS-2015-07-04	03	B