


NOTES:-

1) All survey levels are related to OS Datum (National GPS Network).

2) White Site Surveys has made every effort to locate all topographical and building features we cannot accept responsibility for any features which may be omitted if they are obscured from view for any fixed or temporary reason at the time of the survey taking place.

Legend:-

AV - Air Valve	BC - Mercury Cover
BT - Borehole	BR - Bench Mark
B - Block	MB - Manhole
BT - British Telecom Cover	MR - Manhole Ring
C - Cover (Landscape services)	MS - Manhole Sighting
CL - Cell Level	ODR - Overhead Wires
CL - Column	OTF - O.C. Trip Street
CT - Cable Television Cover	P - Post
D - Drain	PR - Parking Meter
DC - Drain Cover	PS - Public Electric System
EC - Electricity Cover	RE - Rectifying Tank
ED - Electricity Meter	RL - Ridge Level
ES - Earth Stud	RS - Road Sign
FM - Fire Main	SP - Sign Post
FL - Floor Level	SV - Stop Valve
G - Gully	T - Tank
GC - Gas Cover	TFT - Train Pk
GO - Gas Office Box	TJ - Traffic Lights
GT - Gas Tally	TP - Telegraph Pole
IC - Inspection Cover	TV - Cable T.V. Cover
IL - Street Light	VP - Vent Pipe
IS - Street Light Bracket	WC - Water Cover
LB - Lighting Bracket	WM - Water Head Level
LL - Lined Level	WS - Water Level
LP - Lamp Post	WM - Water Meter
LT - Lighting Tower	WT - Water Tally

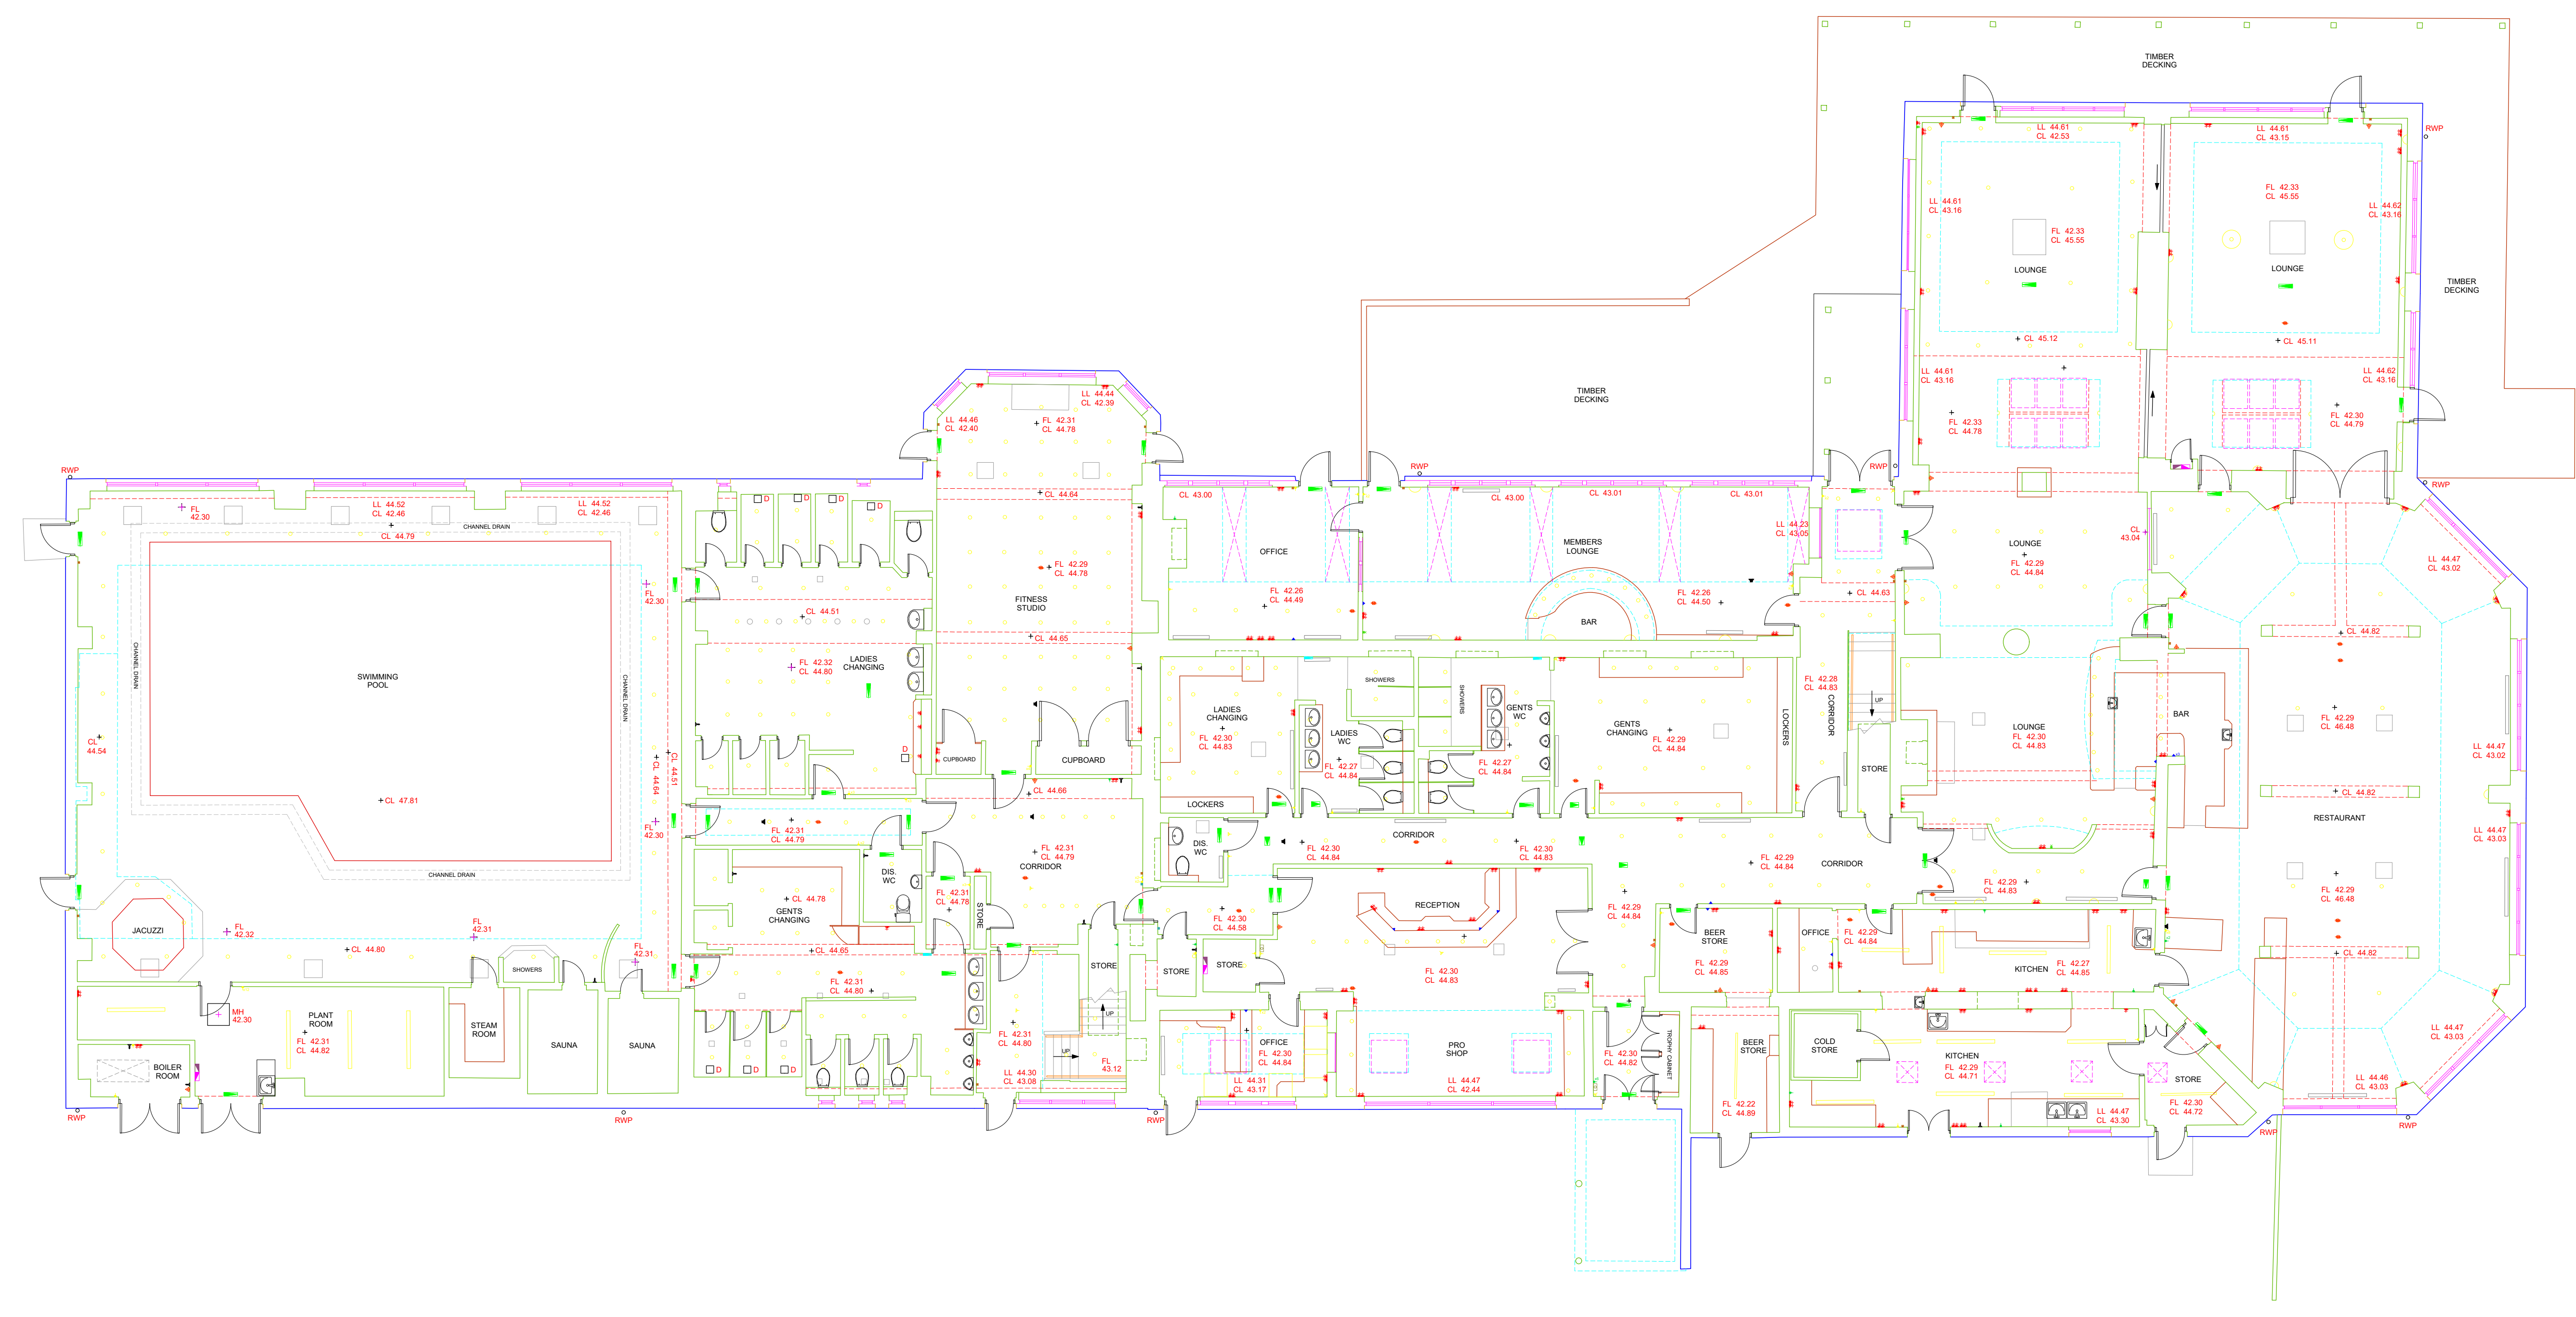

GROUND FLOOR PLAN

SAMPLE DRAWING

Rev.:-	Description:-	Date:-	By:-	Checked

4Site Surveys
 19 CRASGHIRST ROAD
 MILNGAVIE
 GLASGOW
 G62 7RG

Tel/Fax: 0141 956 6764
 email: alan.duggan@4sitesurveys.co.uk
 Web: www.4sitesurveys.co.uk

Client:-

Job Title:-

**WHITEKIRK GOLF CLUB
 WHITEKIRK
 EAST LOTHIAN**

Drawing Title:-	GROUND FLOOR PLAN	Date:-	NOVEMBER 2012
Scale:-	1:100@A0	Drawn By:-	ACF
Surveyed By:-	ACF	Checked By:-	FG
Job Number:-	4SS-2012-11-01	Drawing No.:-	03
Rev.:-	-		